




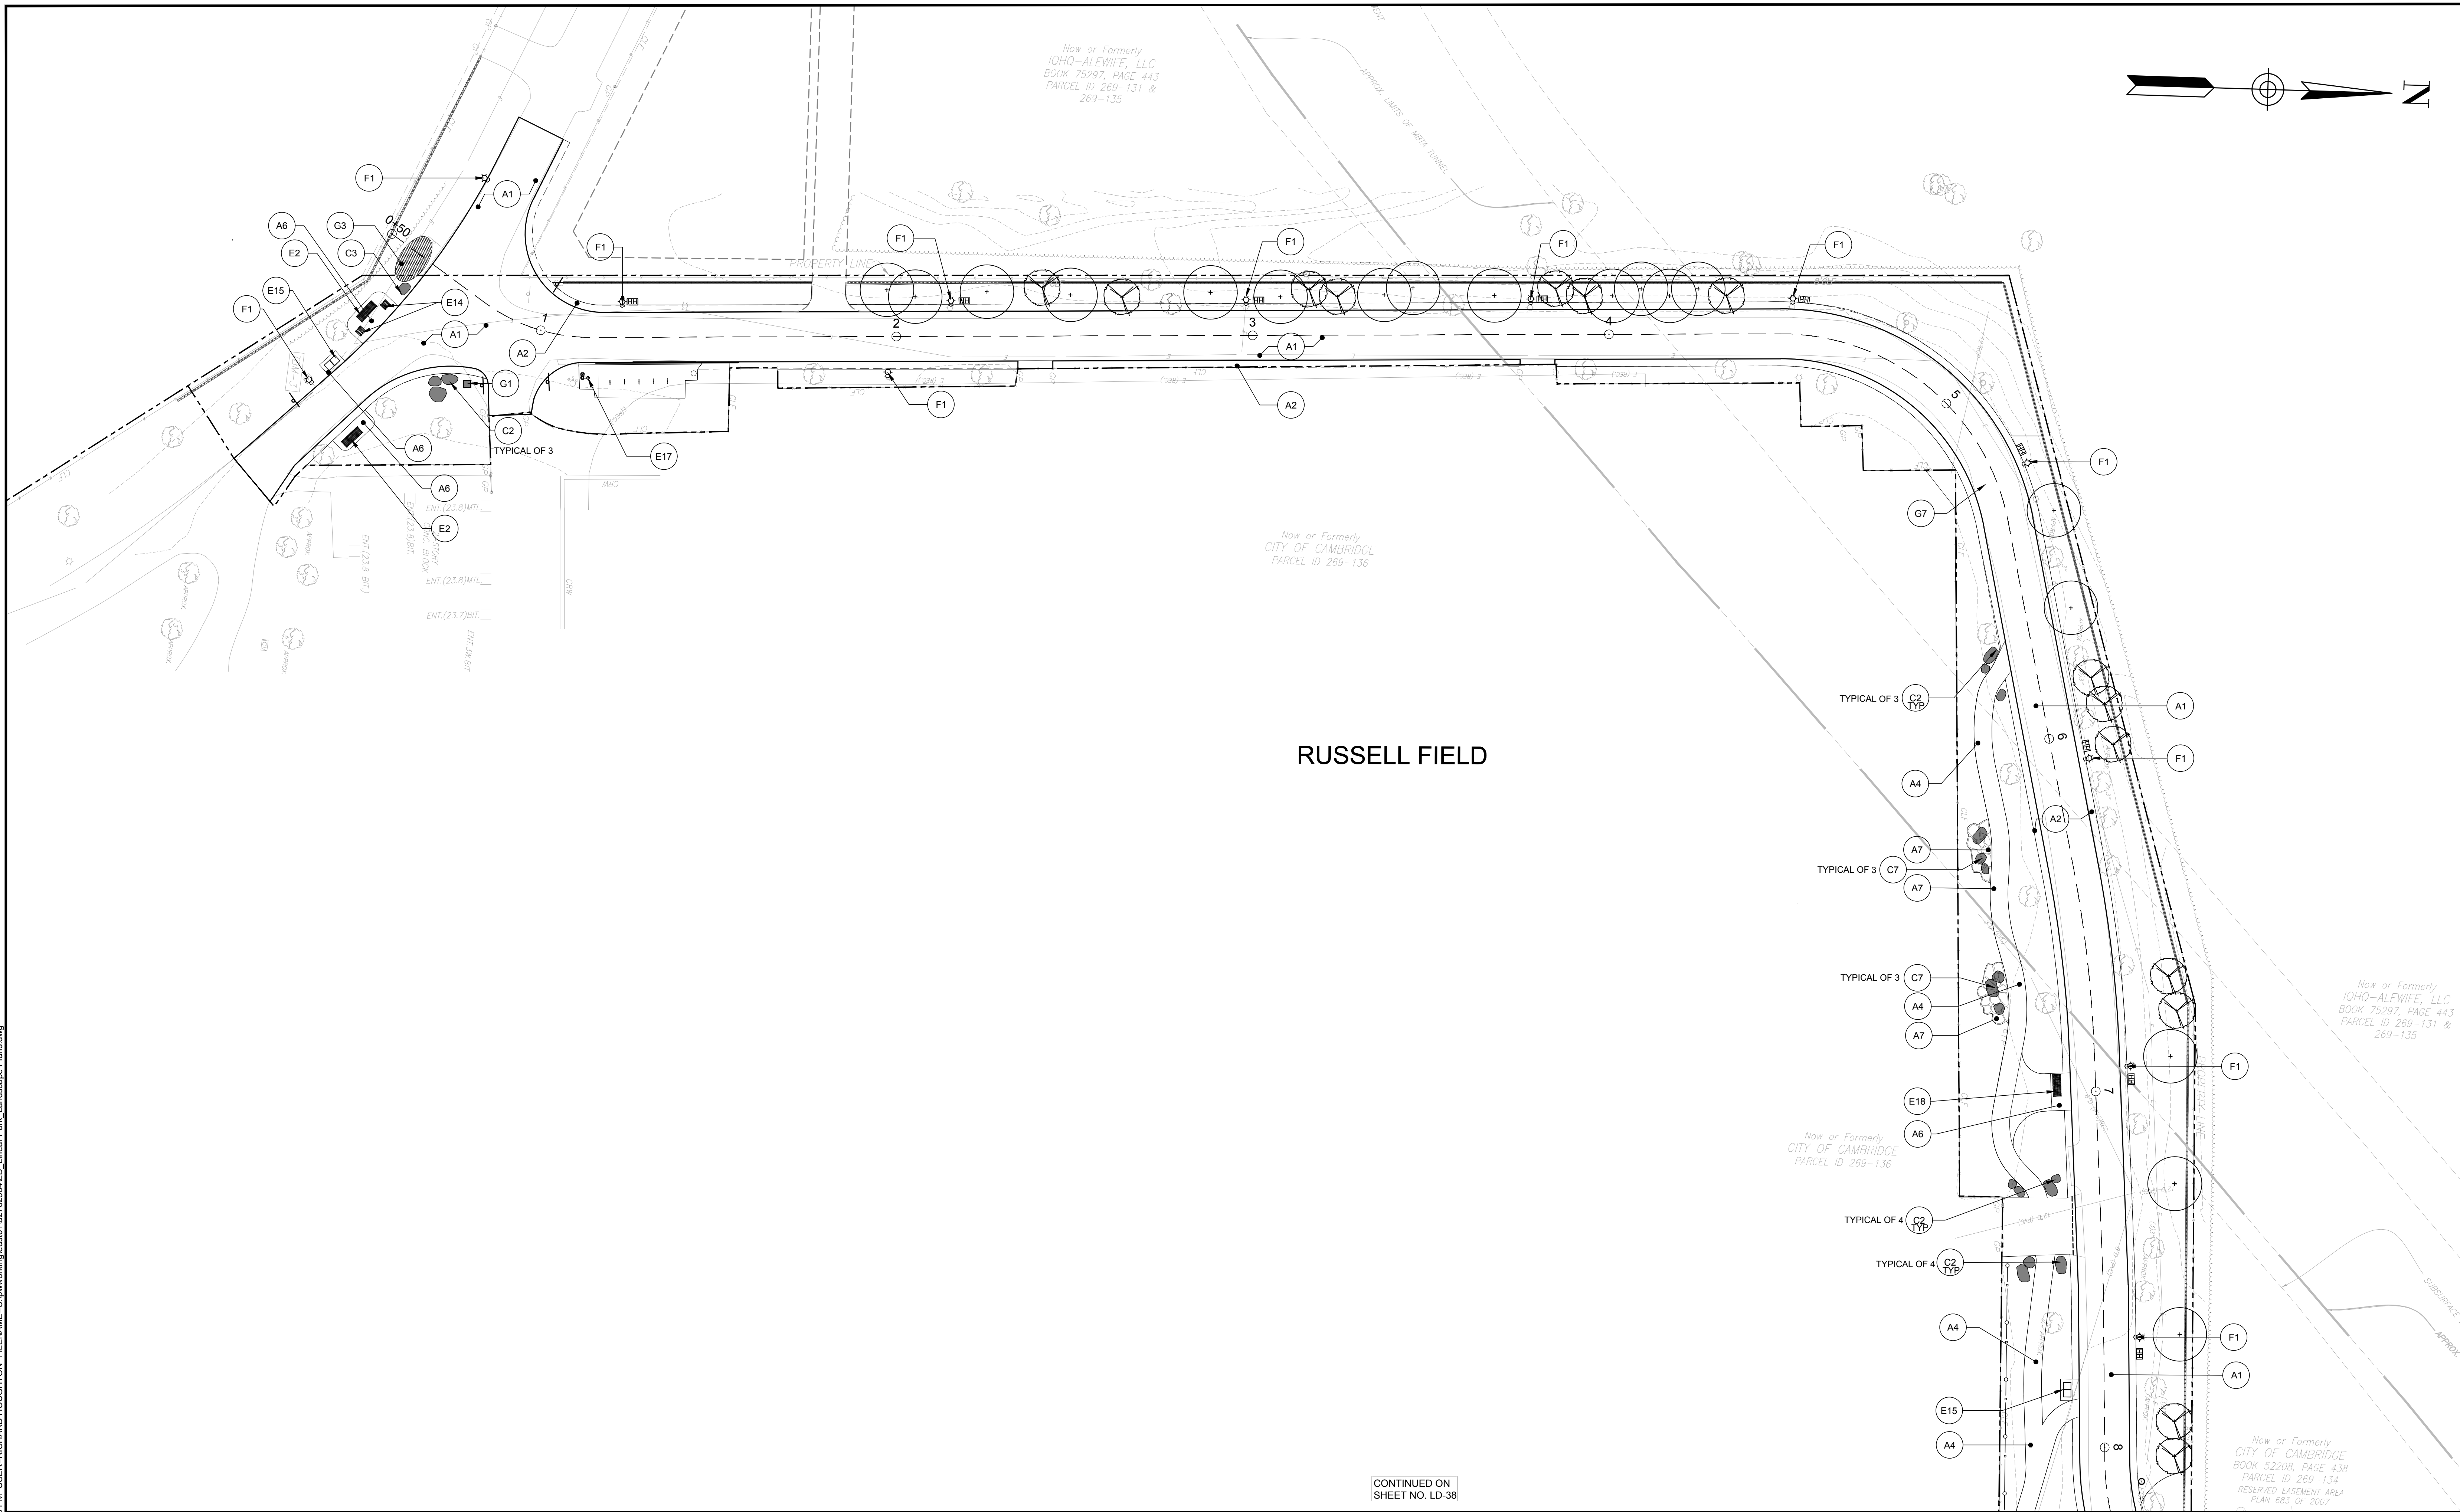
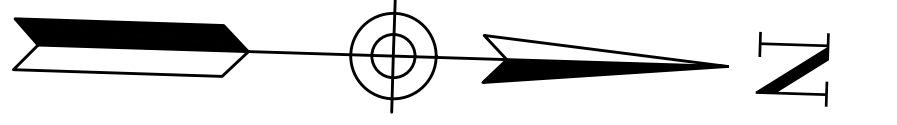
MATERIALS LEGEND

TAG	DESCRIPTION	DETAIL
PAVING		
A1	MULTI-USE PATH - BITUMINOUS CONCRETE PAVING, SEE CIVIL DRAWINGS	
A2	STONE DUST SHOULDER - STABILIZED STONE DUST, SEE CIVIL DRAWINGS	
A3	SECONDARY PATH- BITUMINOUS CONCRETE PAVING, PEDESTRIAN, SEE CIVIL DRAWINGS	
A4	PAVING FIELD TYPE ONE - STABILIZED STONE DUST SECONDARY PATH, SEE CIVIL DRAWINGS	
A5	PAVING FIELD TYPE TWO - BRICK PAVING ON ASPHALT BASE, PEDESTRIAN	1 LD-56 2-4 LD-60
A6	PAVING FIELD TYPE THREE - CAST IN PLACE CONCRETE, SEE CIVIL DRAWINGS	
A7	PAVING FIELD TYPE FOUR - FLAGSTONE PAVING, PEDESTRIAN	3 LD-56 1 LD-60
A8	PAVING FIELD TYPE FIVE - FLAGSTONE PAVING, VEHICULAR	4 LD-56 1 LD-60
A9	RAISED CROSSWALK - SEE CIVIL DRAWINGS	
CURBS		
B1	VEHICULAR ROADWAY CURBING - GRANITE CURBING, SEE CIVIL DRAWINGS	
B2	BRICK EDGING	2 LD-56
B3	ORNAMENTAL GRANITE CURBING - RE-POINTED GRANITE CURB, SEE CIVIL DRAWINGS	
SITE WALLS & STONE ELEMENTS		
C1	FLAGSTONE TREADS AND RISERS	2 LD-57
C2	GRANITE BOULDERS TYPE 1 - NEW ENGLAND FIELDSTONE BOULDERS, 0.5-1.5 CUBIC YARDS (CY) EACH, QUANTITY 1/3 AT 0.5 CY, 1/3 AT 1 CY, 1/3 AT 1.5 CY	5 LD-57
C3	GRANITE BOULDERS TYPE 2 - NEW ENGLAND FIELDSTONE BOULDERS, 0.5-0.75 CUBIC YARDS EACH, FLAT FACE TO ACCEPT BRONZE PLAQUE - PLAQUE TO BE FURNISHED AND INSTALLED BY ARTIST	6 LD-57
C4	GRANITE BOULDERS TYPE 3 - EXTRA LARGE NEW ENGLAND FIELDSTONE BOULDER, 15 CUBIC YARDS EACH	7 LD-57
C5	EXISTING GATEWAY COLUMNS TO REMAIN - REFURBISH IN PLACE, SEE CIVIL DRAWINGS	
C6	GRANITE PROPERTY LINE MARKERS - SEE CIVIL DRAWINGS	
C7	GRANITE STEPPING BOULDER- NEW ENGLAND FIELDSTONE BOULDERS, 0.5-1.5 CUBIC YARDS (CY) EACH, QUANTITY: 1/3 AT 0.5 CY, 1/3 AT 1 CY, 1/3 AT 1.5 CY	4 LD-57
C8	GRANITE JUMPING STONES- NEW ENGLAND FIELDSTONE BOULDERS, 0.25-0.5 CUBIC YARDS EACH	3 LD-57
FENCES & SCREENS		
	FENCE TYPE ONE - ORNAMENTAL FENCE, 4' HEIGHT, SEE CIVIL DRAWINGS	
	FENCE TYPE TWO - ORNAMENTAL FENCE, 5' HEIGHT, SEE CIVIL DRAWINGS	
	PROTECTIVE NETTING AT EXISTING FENCE - SEE CIVIL DRAWINGS	
	PROTECTIVE NETTING AT EXISTING FENCE - SEE CIVIL DRAWINGS	
	7' SECURITY FENCE WITH PRIVACY SLATS - SEE CIVIL DRAWINGS	
	SCREEN FENCE - WOODEN STOCKADE FENCE, 5' HEIGHT, SEE CIVIL DRAWINGS	

TAG	DESCRIPTION	DETAIL
SITE FURNISHINGS		
E1	BIKE RACK	1 LD-59
E2	METAL BENCH - WITH BACK	2 LD-59
E3	METAL GLIDER BENCH - SWINGING METAL BENCH	SIM 2 LD-59
E4	MOVEABLE TABLE AND CHARIS - 4 TOP	5 LD-59 6 LD-59
E5	MOVEABLE TABLE AND CHAIRS - 2 TOP	5 LD-59 6 LD-59
E6	LOG ELEMENT TYPE ONE - VERTICAL, VARIOUS HEIGHTS WOOD STEPPERS	1 LD-58
E7	LOG ELEMENT TYPE TWO - HORIZONTAL WOOD LOGS	2 LD-58
E8	LOG ELEMENT TYPE THREE - WOOD LOG PAVERS, FLUSH CONDITION	1 LD-58
E9	LOG ELEMENT TYPE FOUR - WOOD LOG BALANCE BEAM	4 LD-58
E10	LOG ELEMENT TYPE FIVE - WOOD LOGS SEATING LOGS	3 LD-58
E11	LOG ELEMENT TYPE SIX - UNDER LOGS	5 LD-58
E12	LOG ELEMENT TYPE SEVEN- WOOD LOG TUNNEL	6 LD-58
E13	LOG ELEMENT TYPE EIGHT- WOOD LOG STEP	7 LD-58
E14	METAL CHAIR - WITH BACK	SIM 2 LD-59
E15	TRASH AND RECYCLING RECEPTACLE - NOTE: TWO (2) LOCATIONS WITHOUT SOLAR PANEL OPTION	3 LD-59
E16	BIKE REPAIR STATION	
E17	WATER FILL STATION	4 LD-59
E18	METAL BENCH - BACKLESS	SIM 2 LD-59
E19	ADIRONDACK CHAIR	SIM 6 LD-59
E20	PICNIC TABLE	
	EMERGENCY CALL BOX - SEE CIVIL DRAWINGS	
	DOG WASTE STATION - SIX (6) LOCATIONS TO BE CONFIRMED BY OWNER'S REPRESENTATIVE	
SITE LIGHTING		
F1	LIGHT POLE - CITY STANDARD (CREE THE EDGE SERIES), SEE LIGHTING PLANS	
F2	LIGHT POLE FOR FESTOON LIGHTING	
MISCELLANEOUS LANDSCAPE ELEMENTS		
G1	BRICK AND GRANITE PARK IDENTIFICATION SIGN	1 LD-57
G2	RELOCATED TROLLEY SQUARE ARTIFACT - WITH NEW 6" DEPTH CONCRETE PAD EQUAL IN SIZE TO EXISTING CONCRETE PAD TO BE REMOVED AND SIMILAR MOUNTING / FASTENING AS EXISTING CONDITION	
G3	ART INSTALLATION - TYPE 1A - PREPARE SUBGRADE TO THE ARTIST'S SATISFACTION TO EXTENTS DIRECTED BY THE ARTIST	
G4	ART INSTALLATION - TYPE 1B - PREPARE SUBGRADE TO THE ARTIST'S SATISFACTION TO EXTENTS DIRECTED BY THE ARTIST	
G5	ART INSTALLATION - TYPE 1C - PREPARE SUBGRADE TO THE ARTIST'S SATISFACTION TO EXTENTS DIRECTED BY THE ARTIST	
G6	ART INSTALLATION - TYPE 2A - PREPARE SUBGRADE TO THE ARTIST'S SATISFACTION TO EXTENTS DIRECTED BY THE ARTIST	
G7	IRRIGATION - SEE IRRIGATION DRAWINGS	


PLOT DATE=11/02/2024 8:41:46 PM USER=RICHARD HOUGHTON FILENAME=C:\pwworking\as01\27262584\LD_Linear Park_Landscape_Plans.dwg

 <p>25 KINGTON ST, BOSTON MA 02111-2300 PHONE: 617-232-0388 WWW.HALVORSONDESIGN.COM</p>	 <p>HDR ENGINEERING, INC. 99 HIGH STREET, SUITE 2300 BOSTON, MASSACHUSETTS 02110-2378 (617) 357-7700</p>	Scale NTS Date 11/2024 Job No. 10334207 Designed by RH/PC Drawn by PC Checked by RH Approved by RH	 <p>CAMBRIDGE DEVELOPMENT DIVISION 344 BOWDOIN</p>	Client CITY OF CAMBRIDGE, MA Project ALEWIFE LINEAR PARK RECONSTRUCTION PROJECT Drawing MATERIALS LEGEND	Sheet LD-36 File No.
		REVISIONS			



RUSSELL FIELD


CONTINUED ON SHEET NO. LD-38

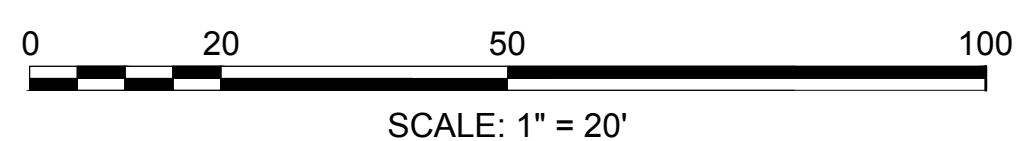

HALVORSON
Tight&Bond studio
25 KINGTON ST, BOSTON MA 02111-2200
PHONE: 617-536-0388
WWW.HALVORSONDESIGN.COM

HDR
HDR ENGINEERING, INC.
99 HIGH STREET, SUITE 2300
BOSTON, MASSACHUSETTS 02110-2378
(617) 357-7700

Scale	1"=20'-0"			
Date	11/2024			
Job No.	10334207			
Designed by	RH/PC			
Drawn by	PC			
Checked by	RH	No.	Description	Date
Approved by	RH		REVISIONS	


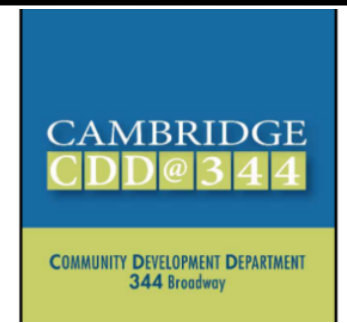


Client	CITY OF CAMBRIDGE, MA
Project	ALEWIFE LINEAR PARK RECONSTRUCTION PROJECT
Drawing	LANDSCAPE MATERIALS PLANS


Sheet	LD-37
File No.	

PLOT DATE=11/02/2024 8:44:26 PM USER=RICHARD HOUGHTON FILENAME=C:\pwworking\h01\2726284\LD_Linear_Park_Landscape_Plans.dwg

 CONTINUED ON SHEET NO. LD-37

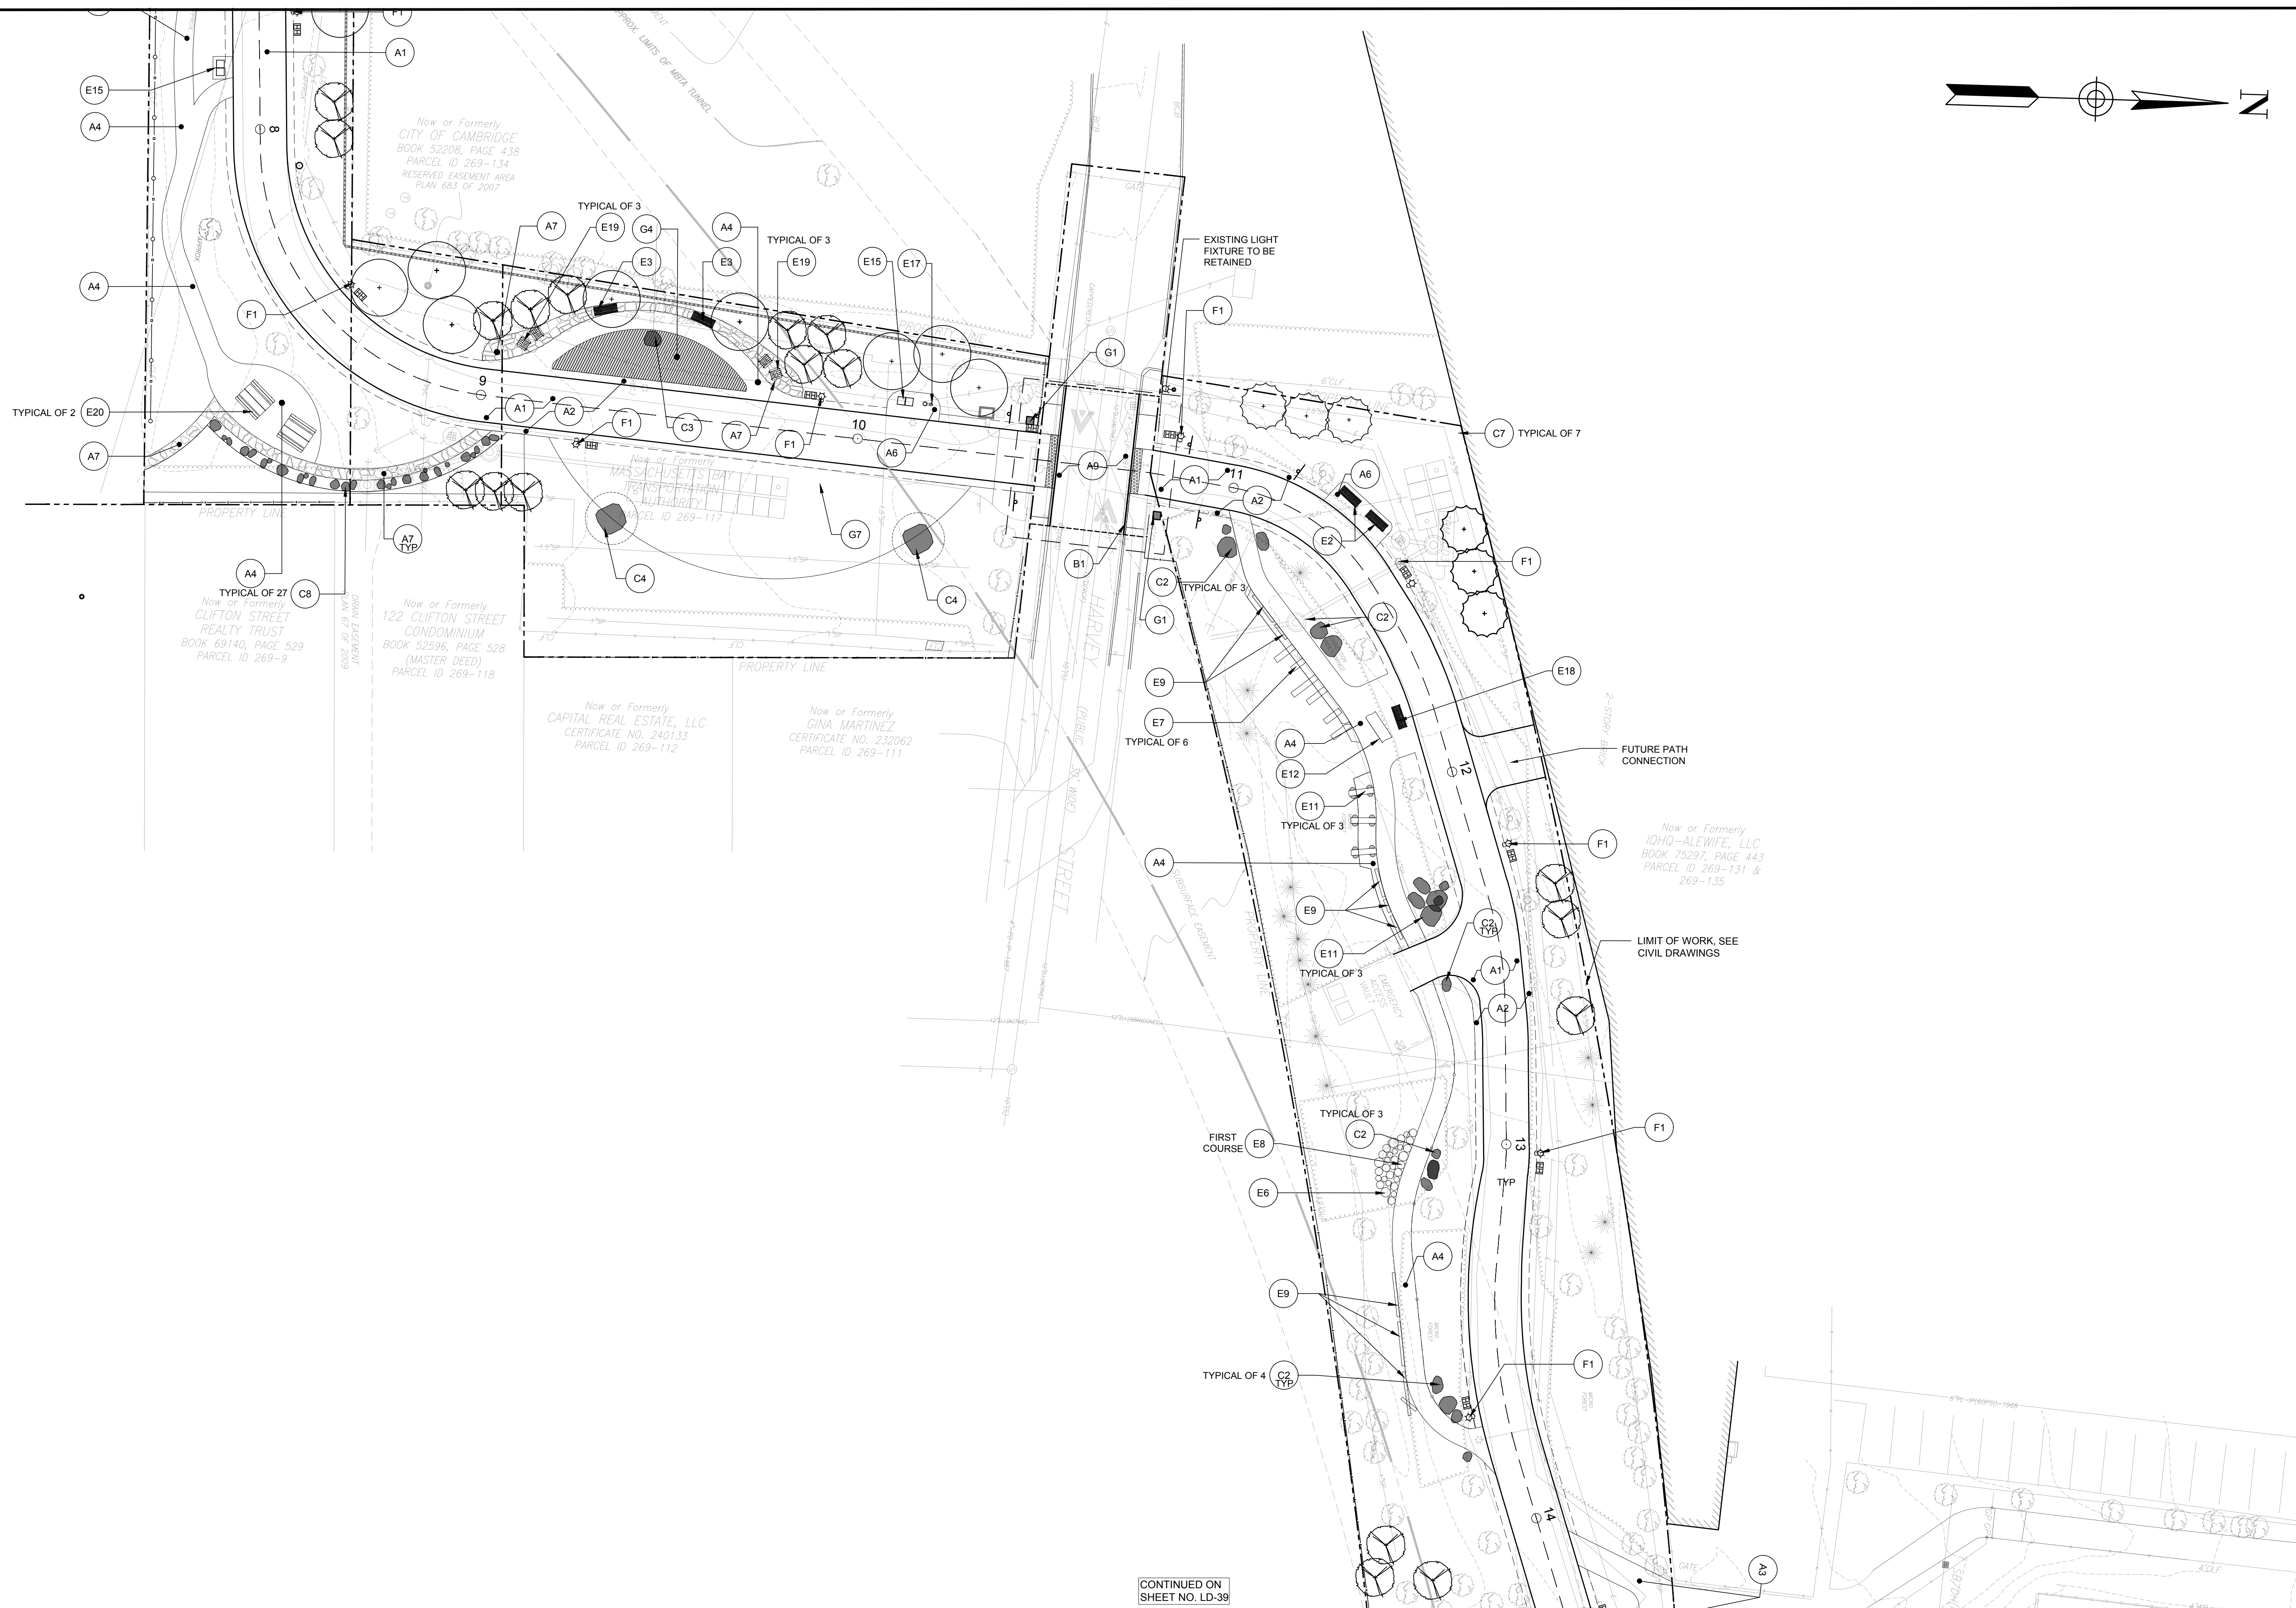

CONTINUED ON SHEET NO. LD-39

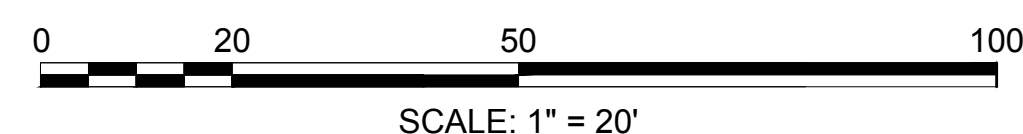


HALVORSON
Tight&Bond studio

25 KINGSTON ST., BOSTON MA 02111-2200
PHONE: 617-546-0380
WWW.HALVORSONDESIGN.COM



HDR ENGINEERING, INC.
99 HIGH STREET, SUITE 2300
BOSTON, MASSACHUSETTS 02110-2378
(617) 357-7700


Scale	1"=20'-0"			
Date	11/2024			
Job No.	10334207			
Designed by	RH/PC			
Drawn by	PC			
Checked by	RH	No.	Description	Date
Approved by	RH		REVISIONS	

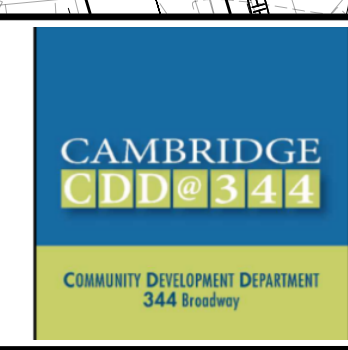


Client	CITY OF CAMBRIDGE, MA
Project	ALEWIFE LINEAR PARK RECONSTRUCTION PROJECT
Drawing	LANDSCAPE MATERIALS PLANS

Sheet	LD-38
File No.	

PLOT DATE: 11/20/2024 8:45:53 PM USER: RICHARD HOUGHTON FILENAME: C:\pwworking\houghton\10272284\LD_Linear Park_Landscape Plans.dwg

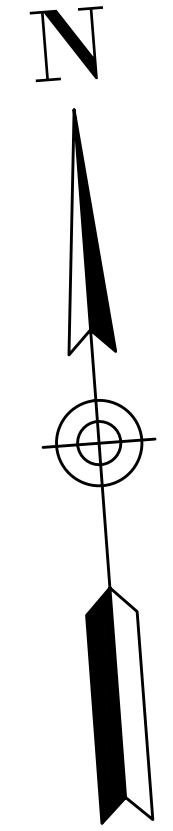


WHITTEMORE (PUBLIC - 40' WIDE) AVENUE

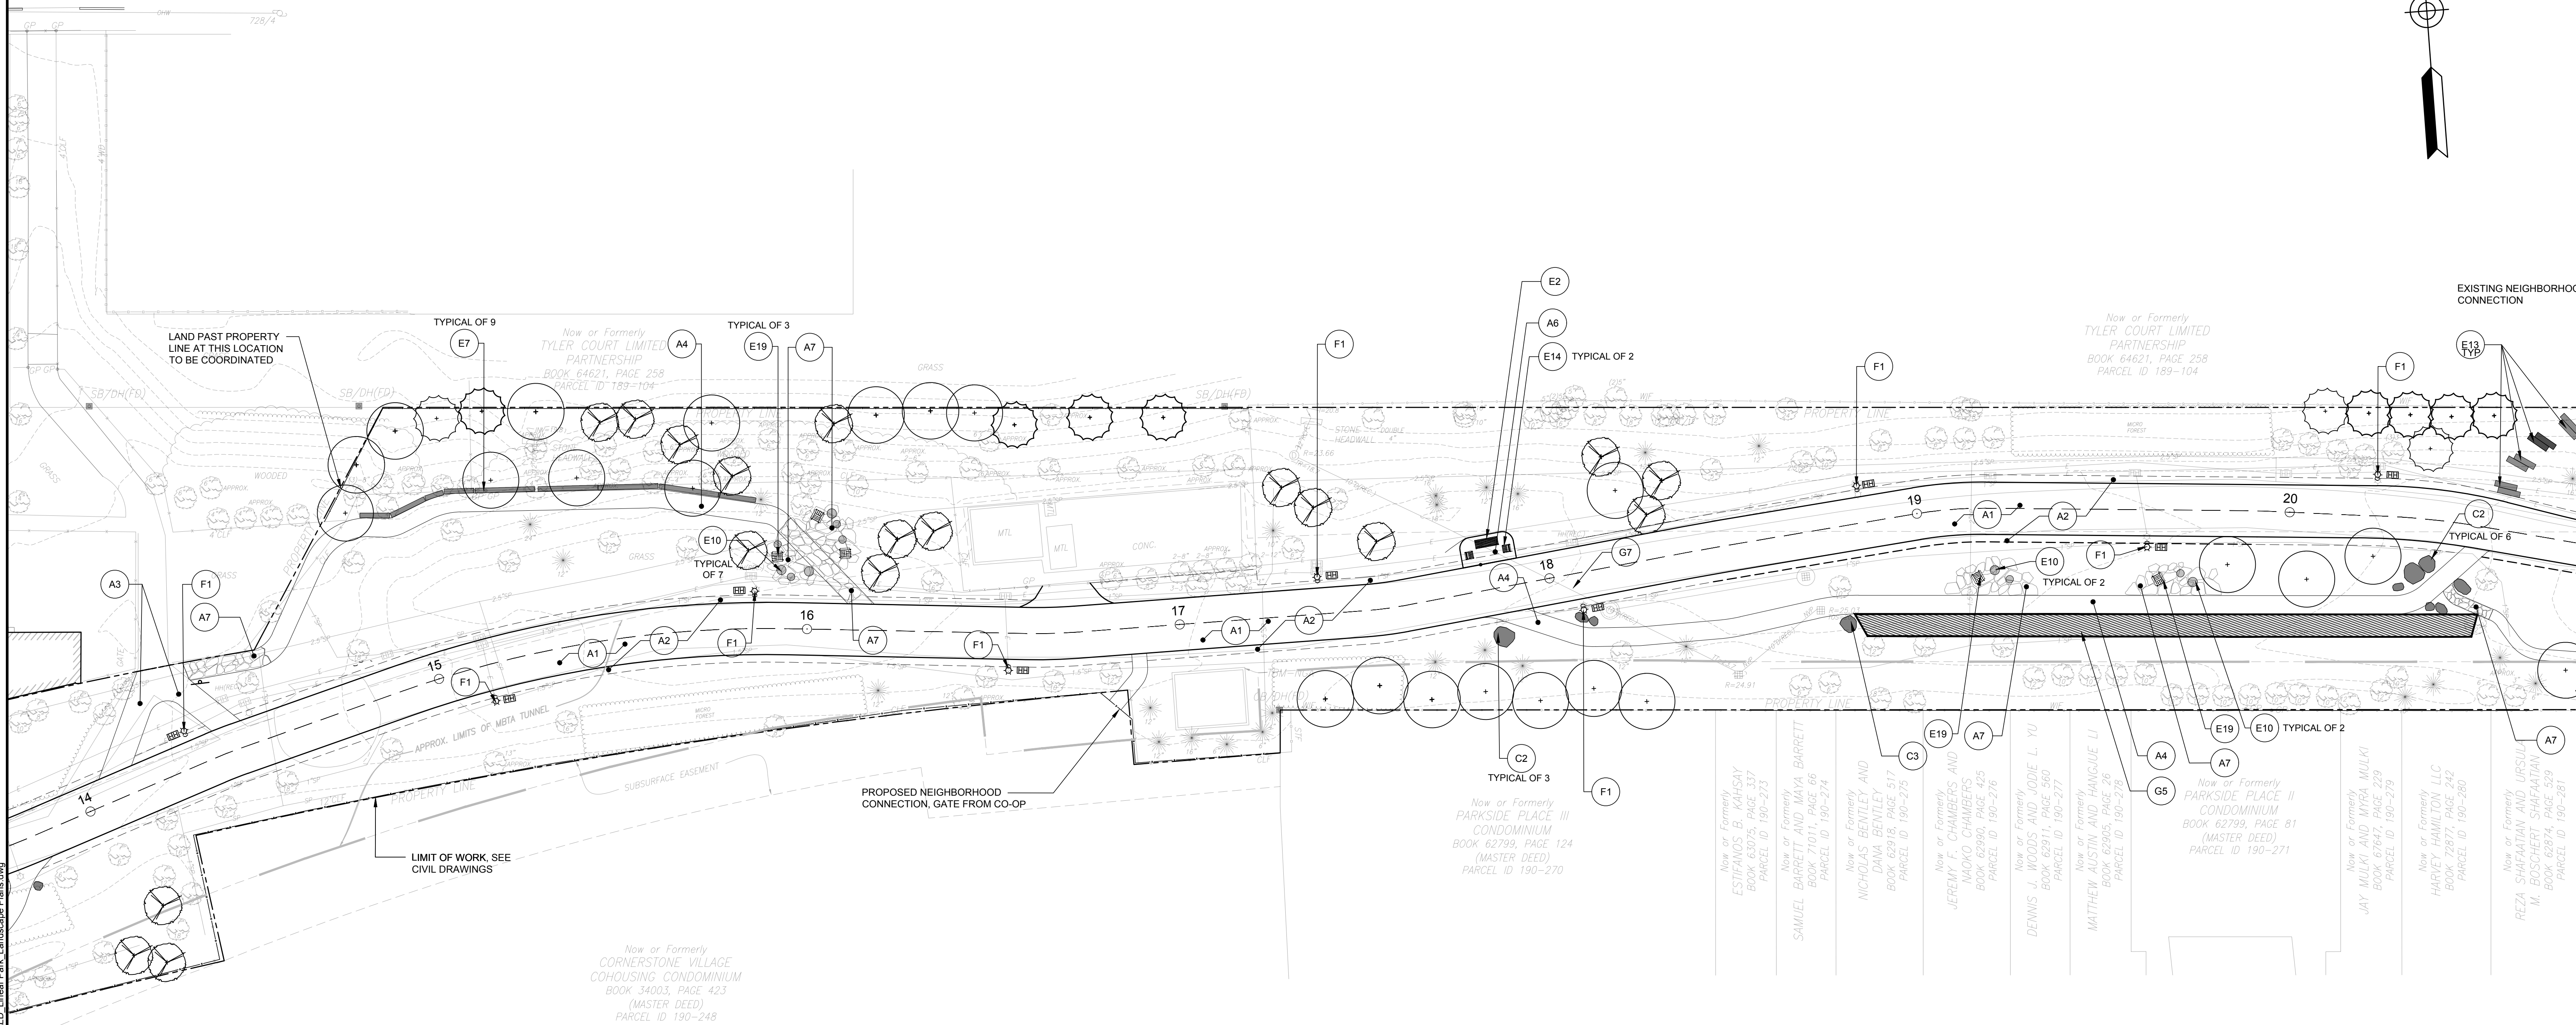

CONTINUED ON SHEET NO. LD-38

CONTINUED ON SHEET NO. LD-40

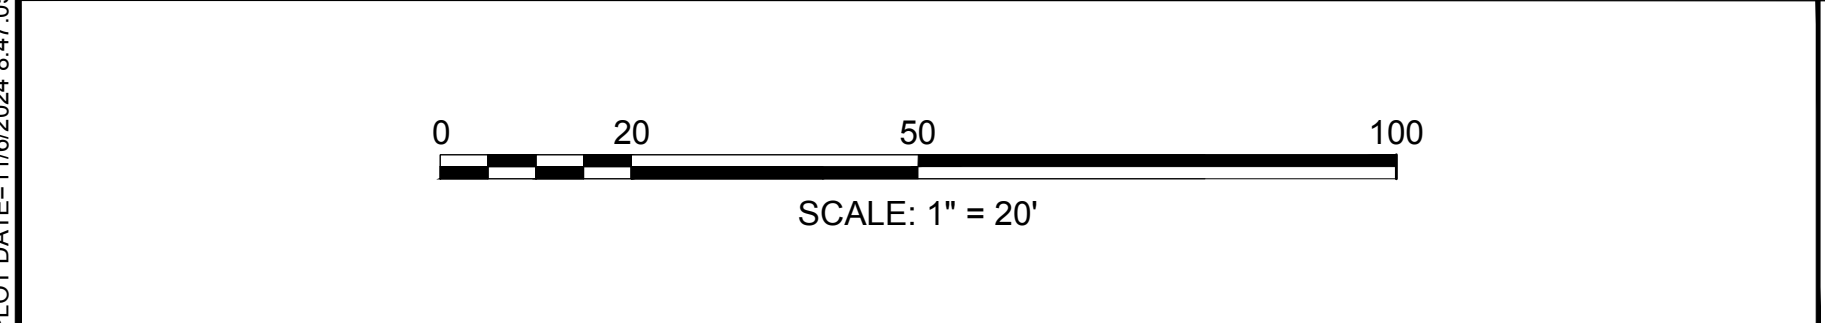


HALVORSON
Tight&Bond STUDIO

25 KINGSTON ST. BOSTON MA 02111-2206
PHONE: 617-536-0381
WWW.HALVORSONDESIGN.COM

HDR

HDR ENGINEERING, INC.
99 HIGH STREET, SUITE 2300
BOSTON, MASSACHUSETTS 02110-2378
(617) 357-7700



Scale	1"=20'-0"		
Date	11/2024		
Job No.	10334207		
Designed by	RH/PC		
Drawn by	PC		
Checked by	RH	No.	Description
Approved by	RH		REVISIONS

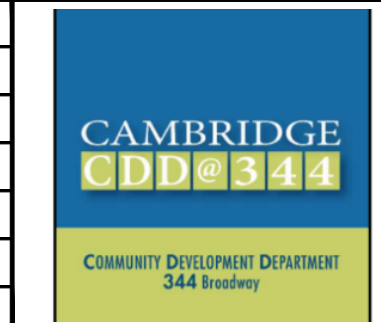

Client	CITY OF CAMBRIDGE, MA
Project	ALEWIFE LINEAR PARK RECONSTRUCTION PROJECT
Drawing	LANDSCAPE MATERIALS PLANS

Sheet	LD-39
File No.	


PLOT DATE: 11/26/2024 8:47:06 PM USER: RICHARD HOUGHTON FILENAME: C:\pwworking\hous01\22282884\LD_Linear Park_Landscape Plans.dwg

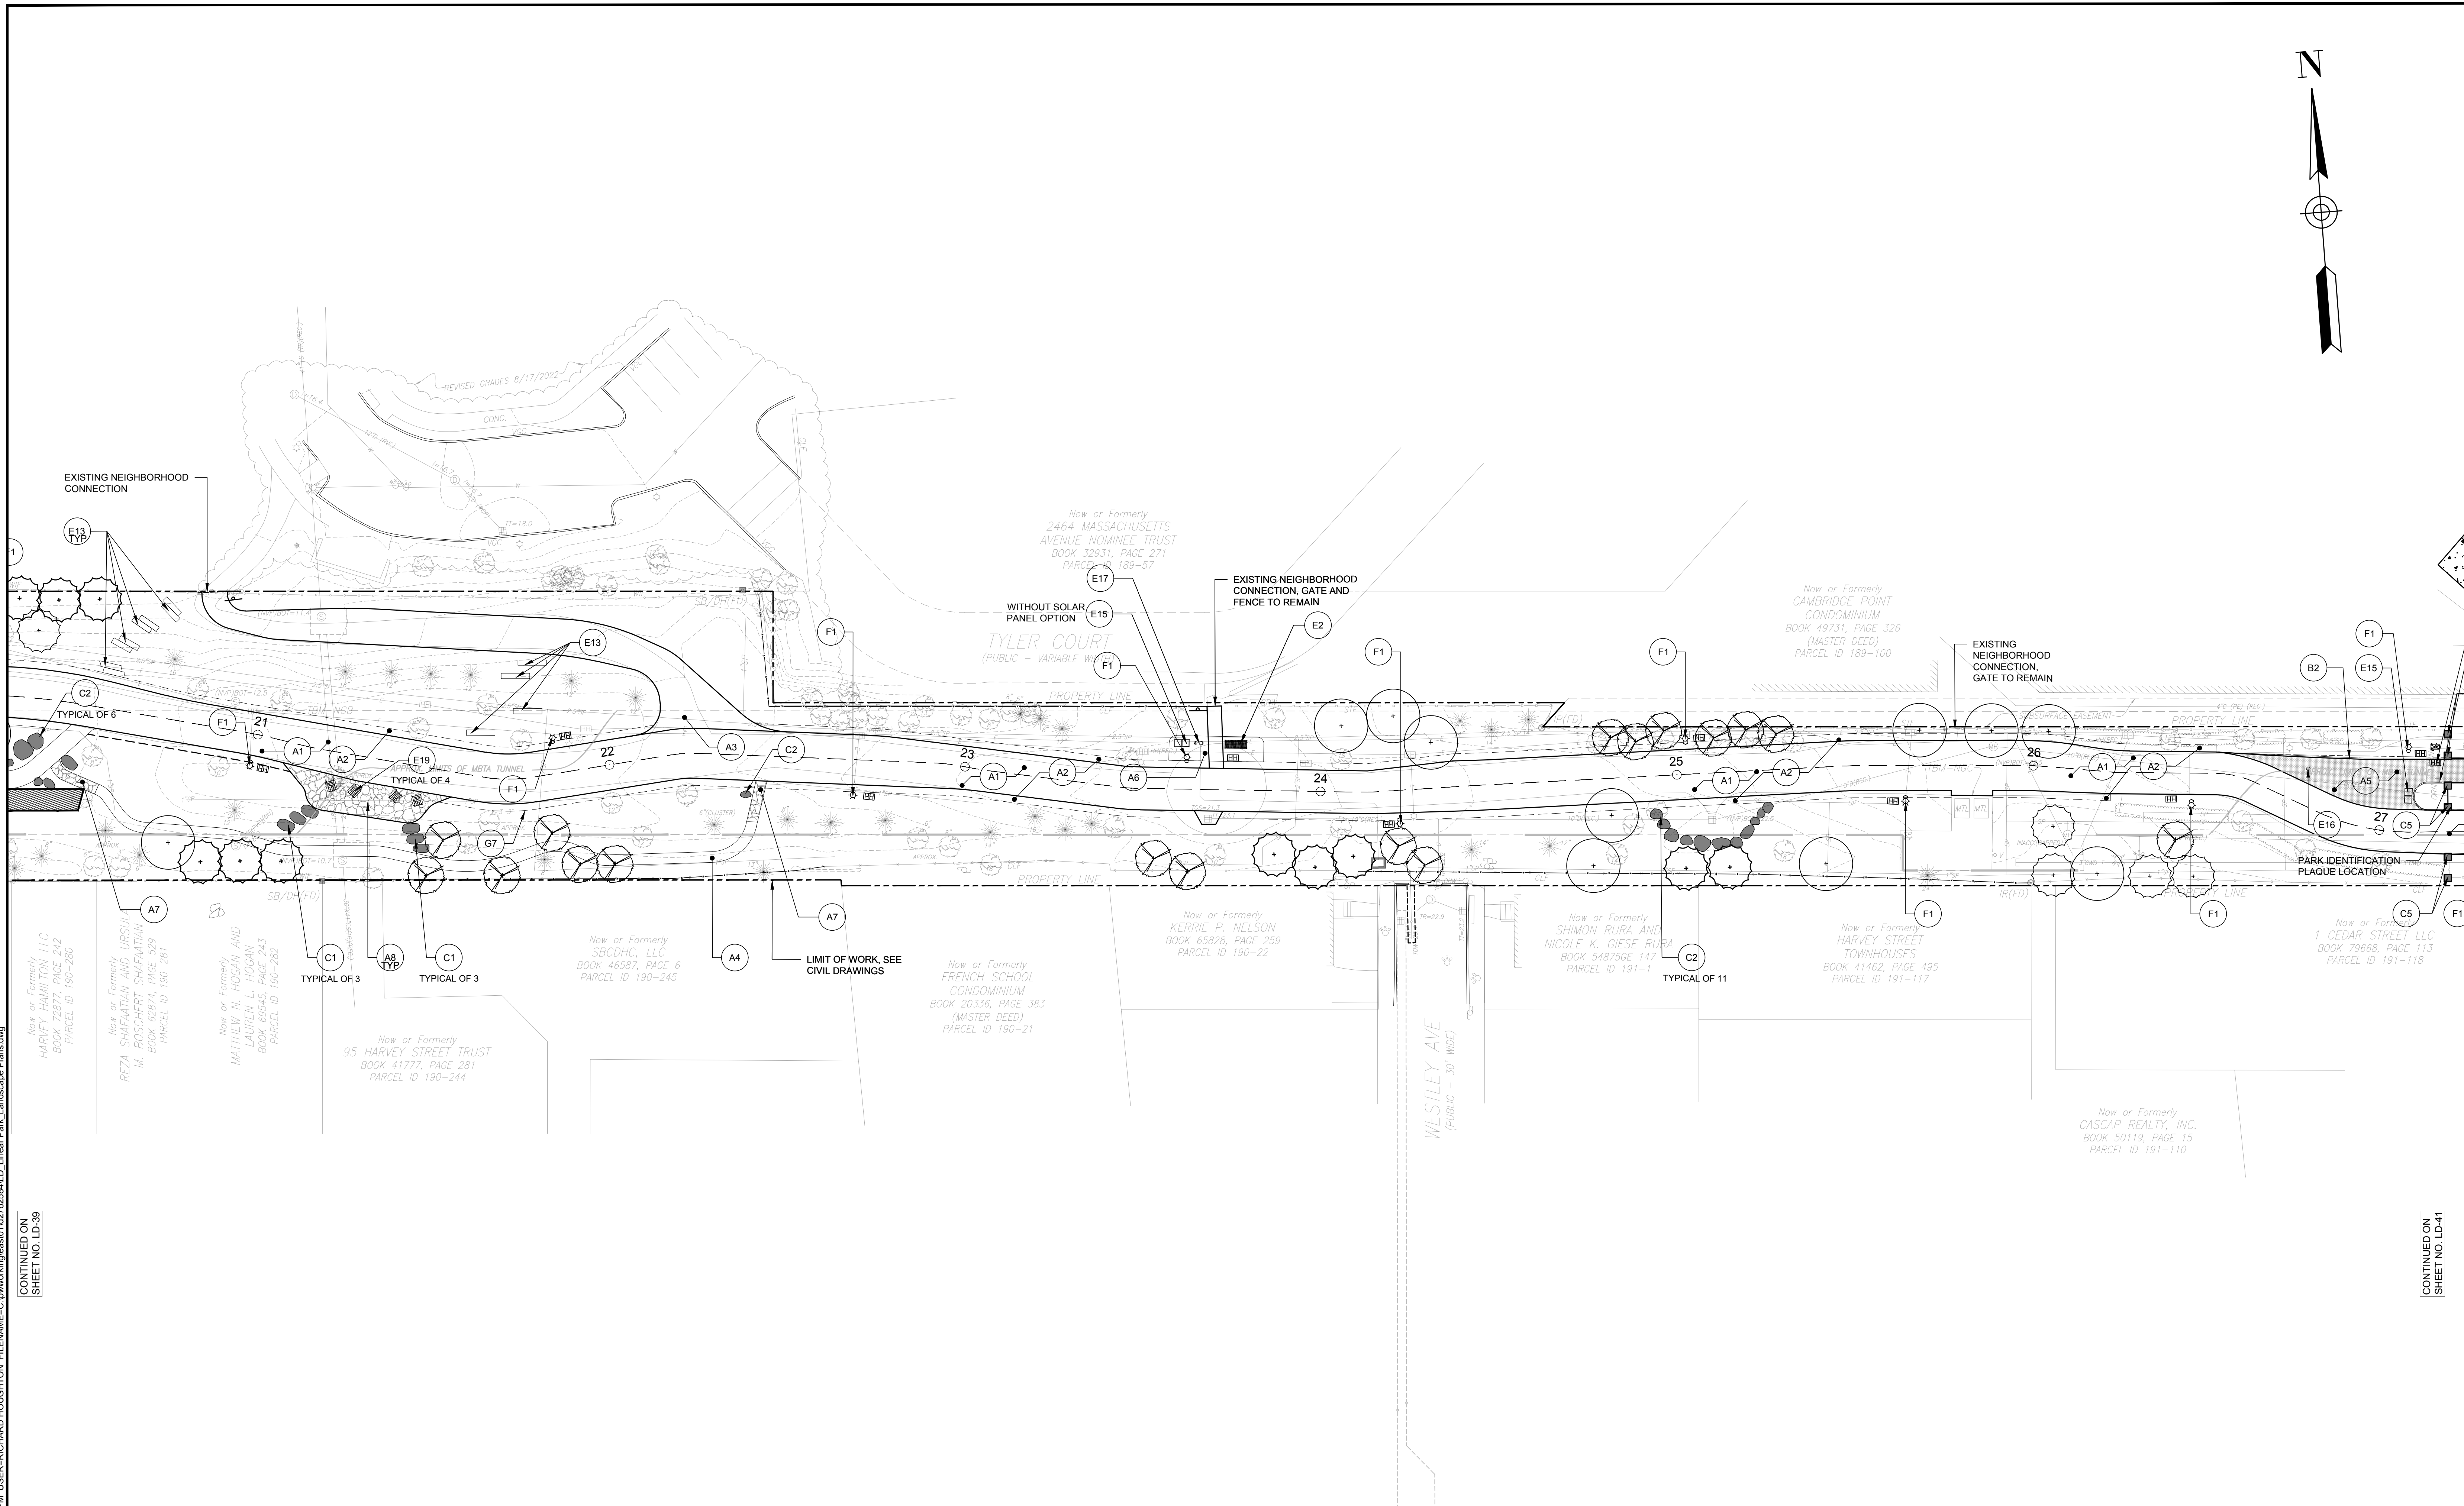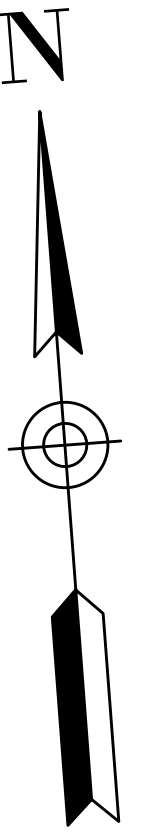

PLOT DATE: 11/20/2024 8:48:39 PM USER: RICHARD HOUGHTON FILENAME: C:\working\alewife\alewife_linear_park_landscape_plans.dwg

CONTINUED ON SHEET NO. LD-39

CONTINUED ON SHEET NO. LD-41

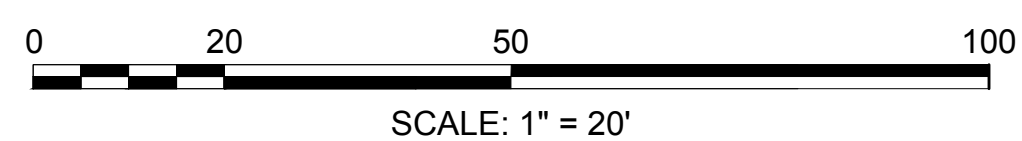


HALVORSON
Tight&Bond studio

25 KINGSTON ST. BOSTON MA 02111-2200
PHONE: 617-536-0380
WWW.HALVORSONDESIGN.COM





HDR ENGINEERING, INC.
99 HIGH STREET, SUITE 2300
BOSTON, MASSACHUSETTS 02110-2378
(617) 357-7700

Scale	1"=20'-0"		
Date	11/2024		
Job No.	10334207		
Designed by	RH/PC		
Drawn by	PC		
Checked by	RH	No.	Description
Approved by	RH		REVISIONS

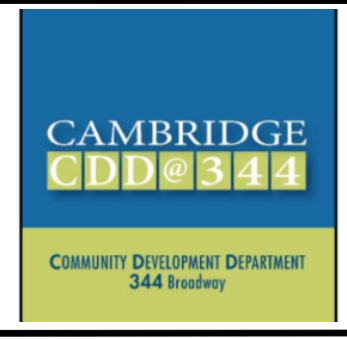


Client	CITY OF CAMBRIDGE, MA
Project	ALEWIFE LINEAR PARK RECONSTRUCTION PROJECT
Drawing	LANDSCAPE MATERIALS PLANS

Sheet	LD-40
File No.	

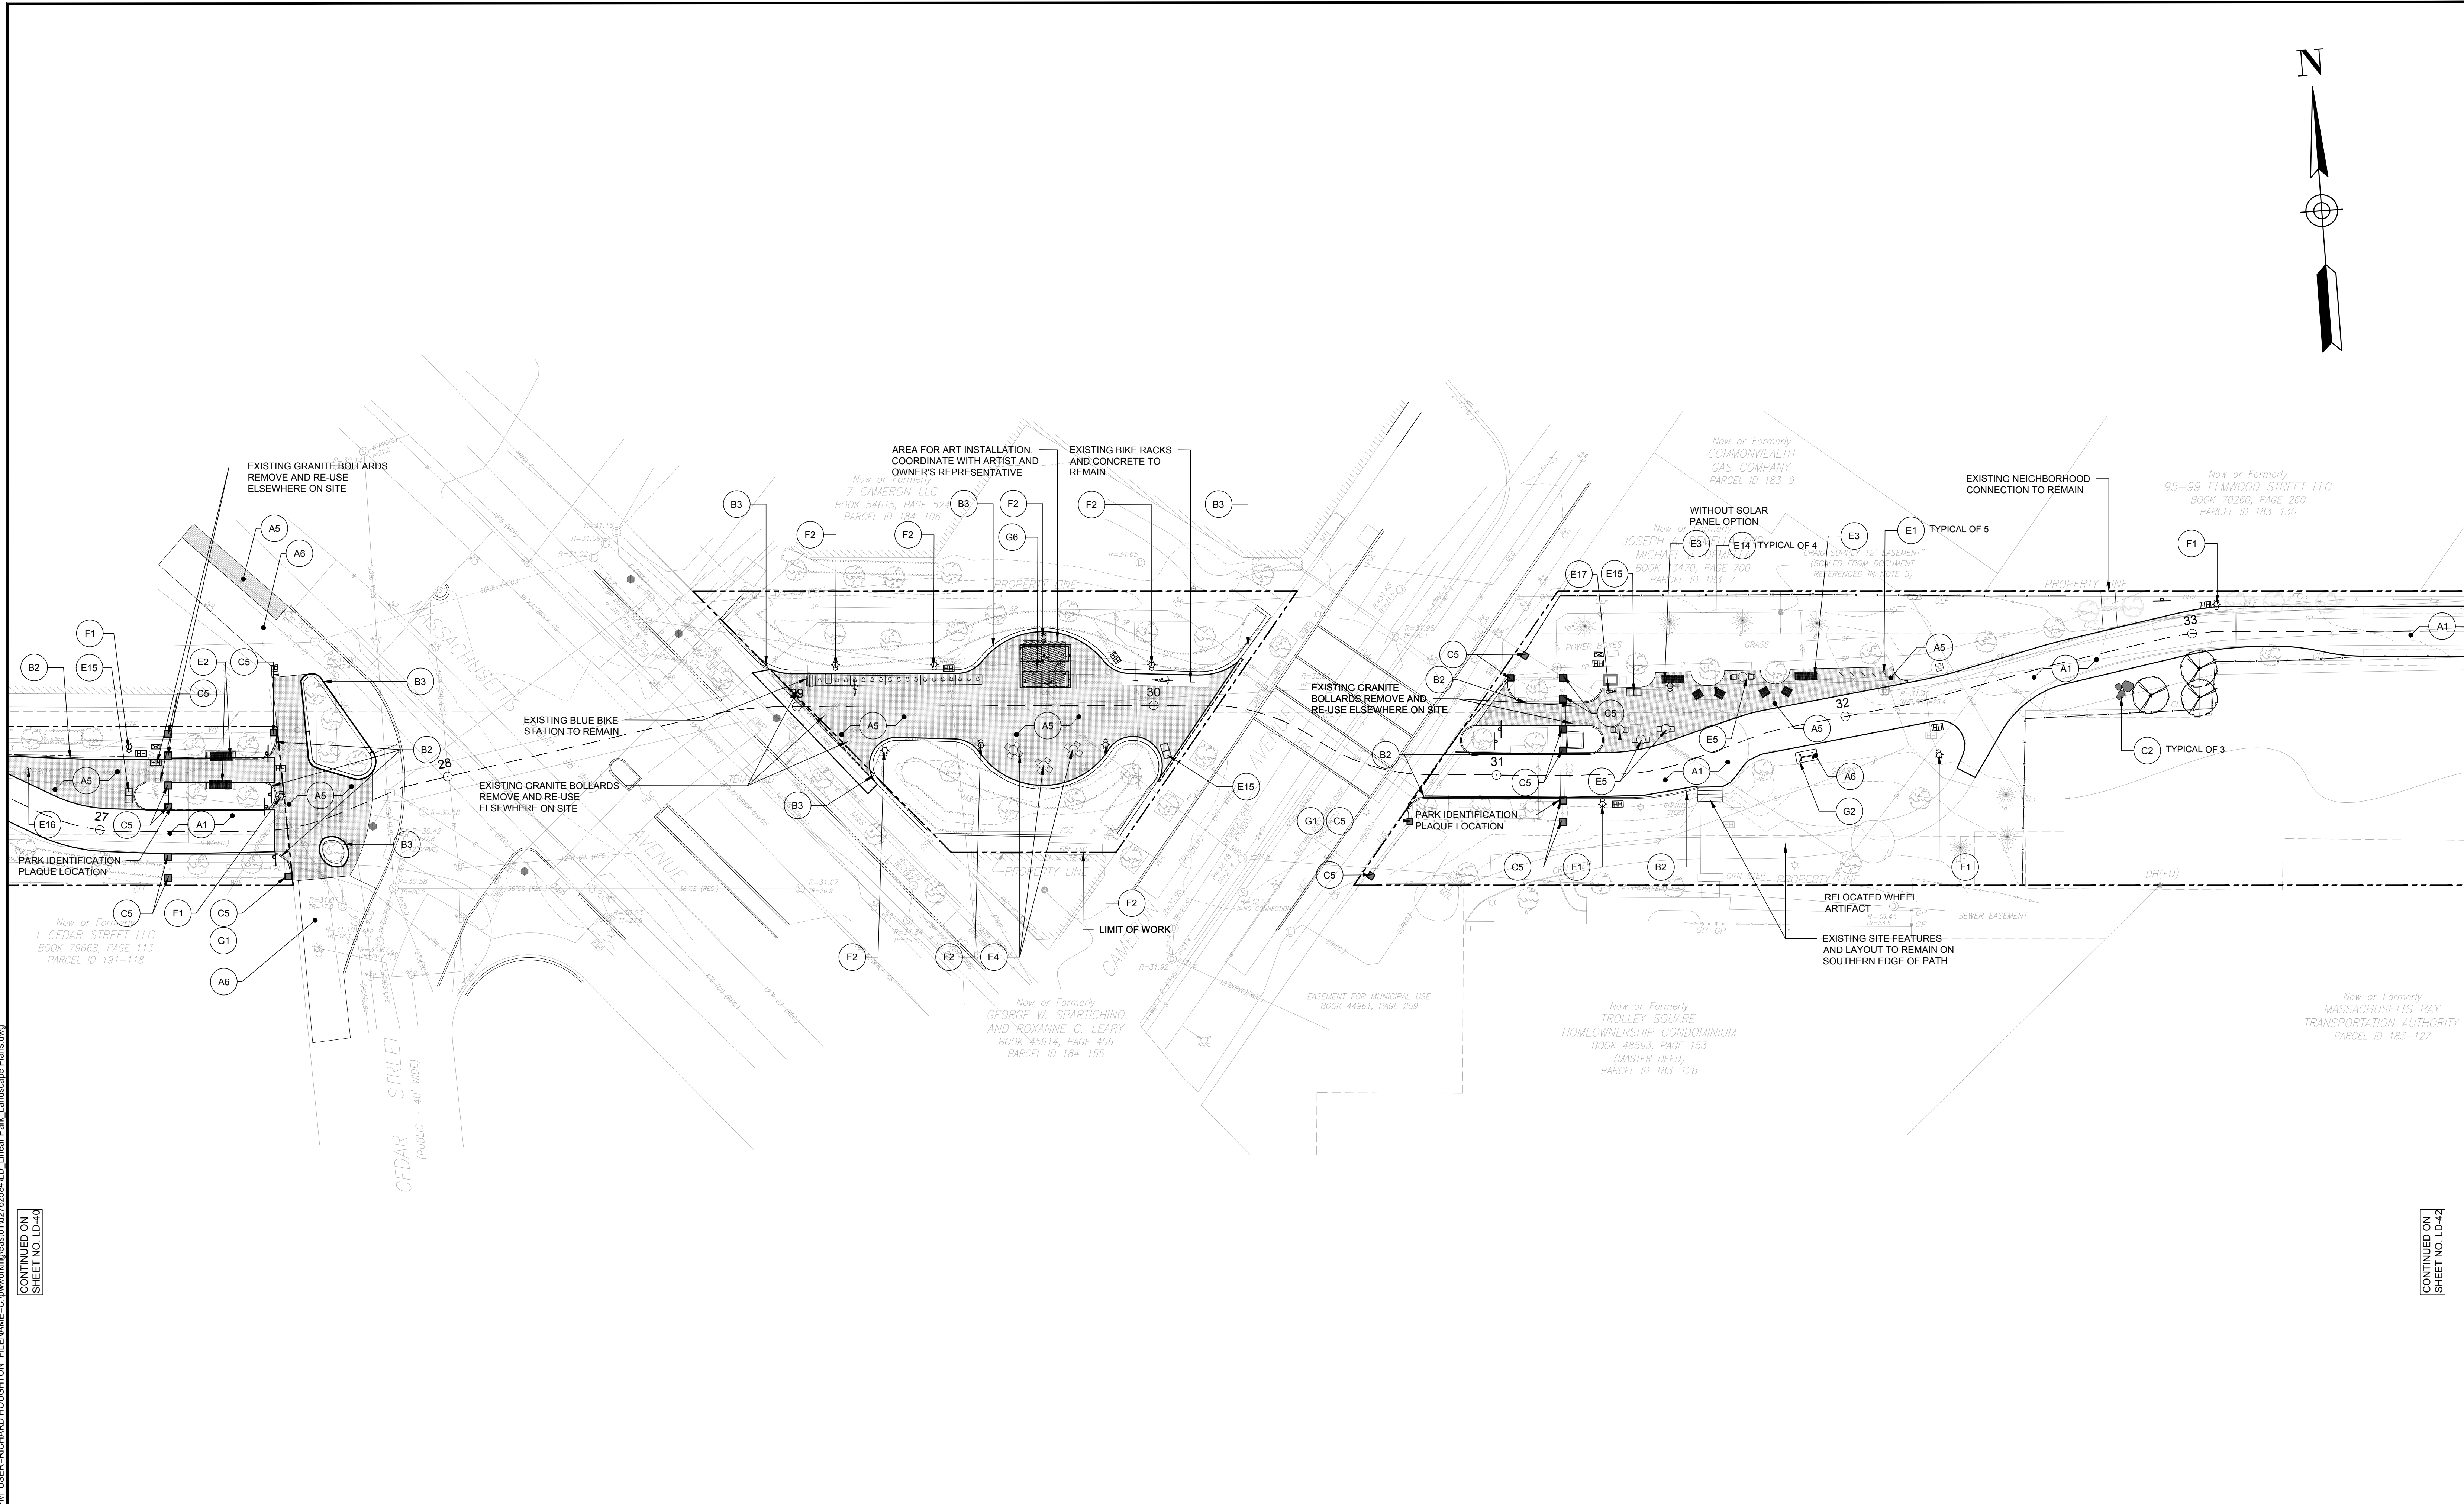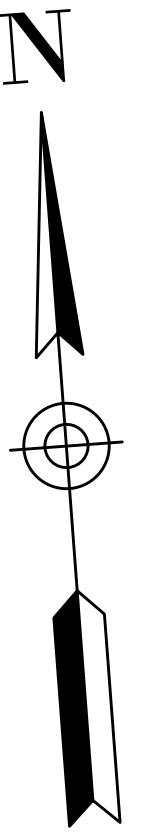


CONTINUED ON SHEET NO. LD-40

CONTINUED ON SHEET NO. LD-42

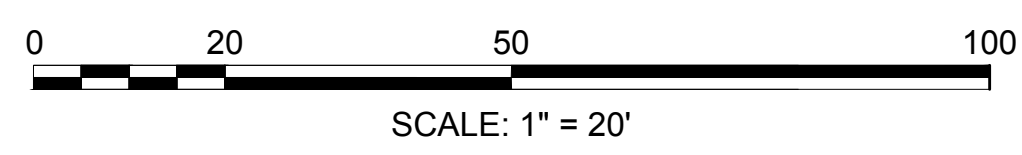


HALVORSON
Tight&Bond STUDIO

25 KINGSTON ST. BOSTON MA 02111-2900
PHONE: 617-536-0380
WWW.HALVORSONDESIGN.COM

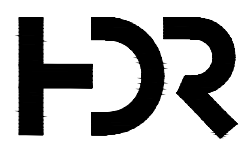



HDR ENGINEERING, INC.
99 HIGH STREET, SUITE 2300
BOSTON, MASSACHUSETTS 02110-2378
(617) 357-7700

Scale	1"=20'-0"		
Date	11/2024		
Job No.	10334207		
Designed by	RH/PC		
Drawn by	PC		
Checked by	RH	No.	Description
Approved by	RH		DATE
REVISIONS			

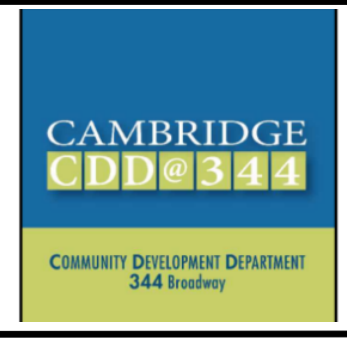


Client	CITY OF CAMBRIDGE, MA
Project	ALEWIFE LINEAR PARK RECONSTRUCTION PROJECT
Drawing	LANDSCAPE MATERIALS PLANS

Sheet	LD-41
File No.	

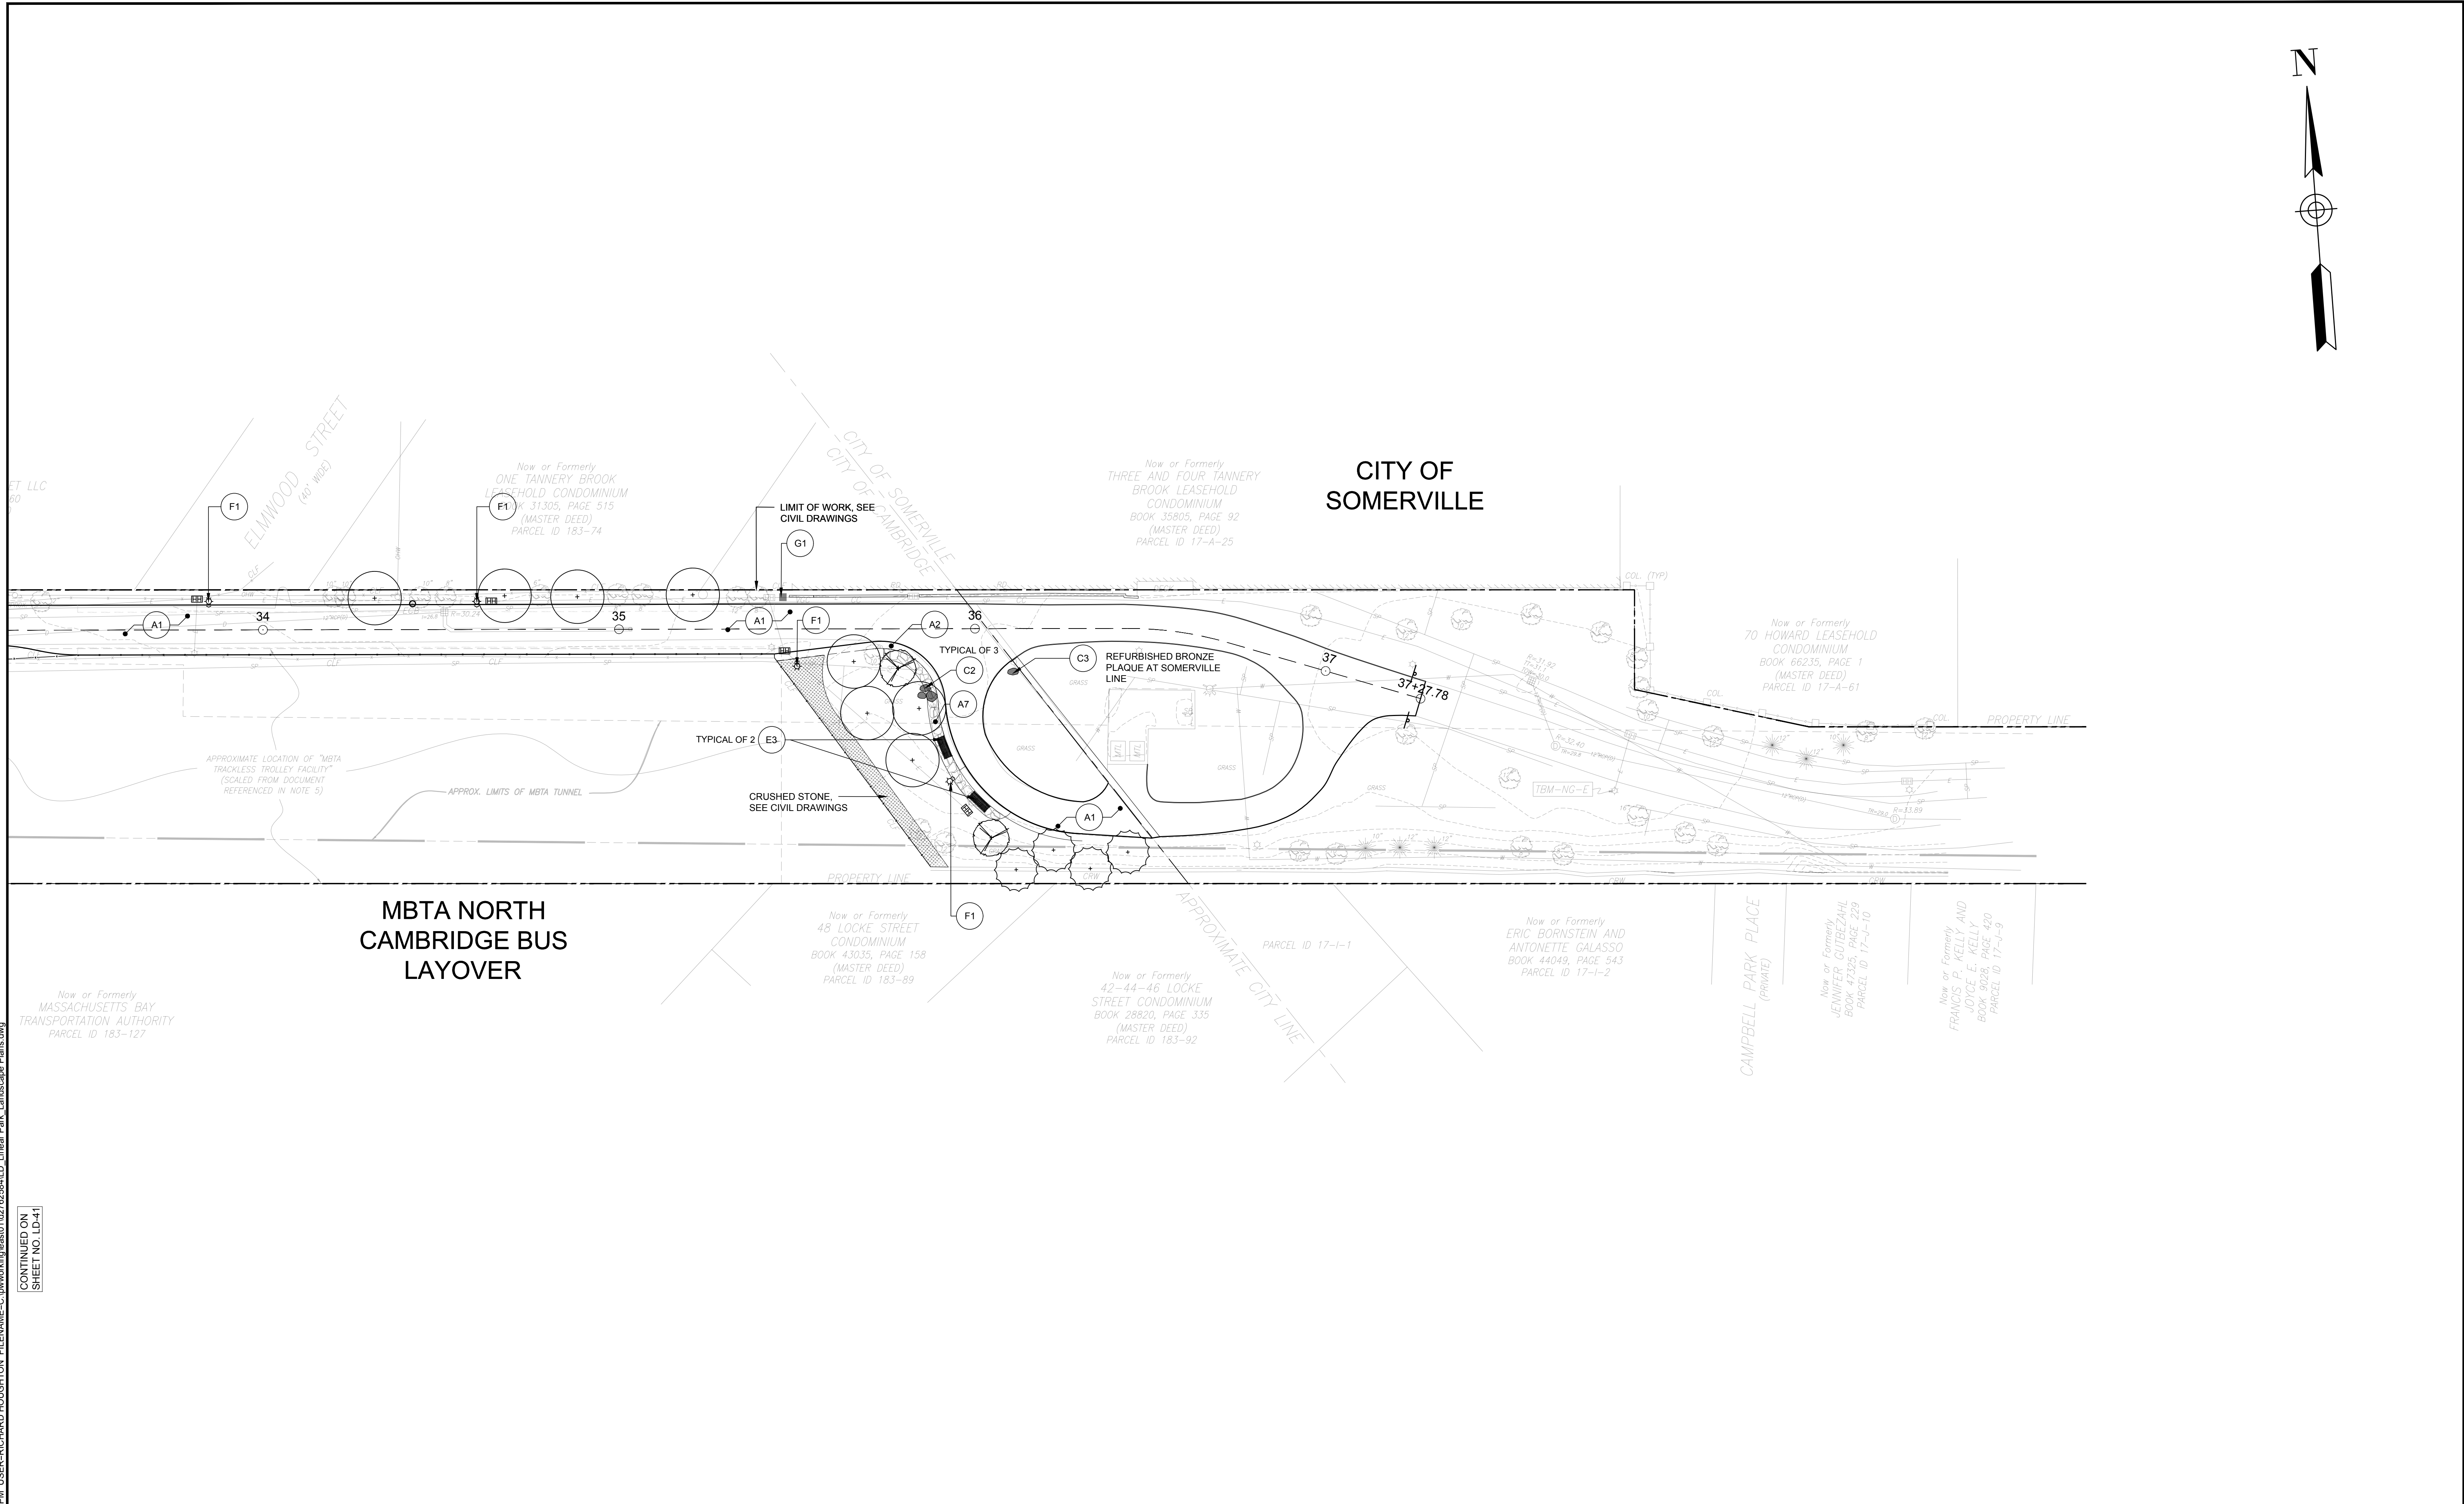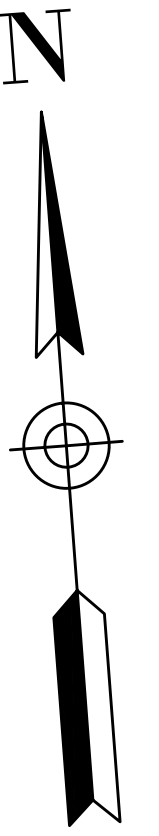

PLOT DATE: 11/22/2024 8:50:50 PM USER: RICHARD HOUGHTON FILENAME: C:\pwworking\houghton\12726284\LD_Linear Park Landscape Plans.dwg


CONTINUED ON SHEET NO. LD-41

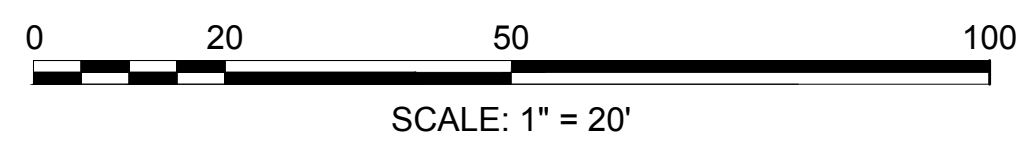

HALVORSON
Tight & Bond STUDIO
25 KINGSTON ST. BOSTON MA 02111-2200
PHONE: 617-536-0380
WWW.HALVORSONDESIGN.COM

HDR
HDR ENGINEERING, INC.
99 HIGH STREET, SUITE 2300
BOSTON, MASSACHUSETTS 02110-2378
(617) 357-7700

Scale	1"=20'-0"			
Date	11/2024			
Job No.	10334207			
Designed by	RH/PC			
Drawn by	PC			
Checked by	RH	No.	Description	Date
Approved by	RH		REVISIONS	

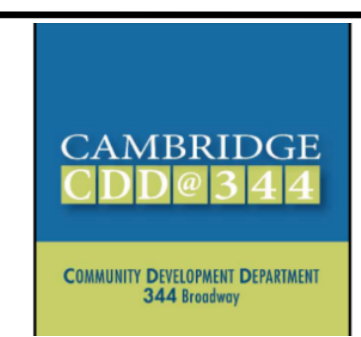

Client	CITY OF CAMBRIDGE, MA
Project	ALEWIFE LINEAR PARK RECONSTRUCTION PROJECT
Drawing	LANDSCAPE MATERIALS PLANS

Sheet	LD-42
File No.	